





Consultants



Legend



Notes

Revision	By	App'd	DATE

Development Permit	AXSP	CISM	2018/1
Issued	By	App'd	DATE

Permit-5eol




VANCOUVER ISLAND HEALTH AUTHORITY  
ELECTRICAL ENERGY CENTRE  
1200 Dufferin Crescent, Nanaimo, BC V9S 2B7

Title  
SITE PLAN - NEW

Project No.	Scale
144315071	As indicated
Revision	Drawing No.

Sheet  
of 1 **A-102**

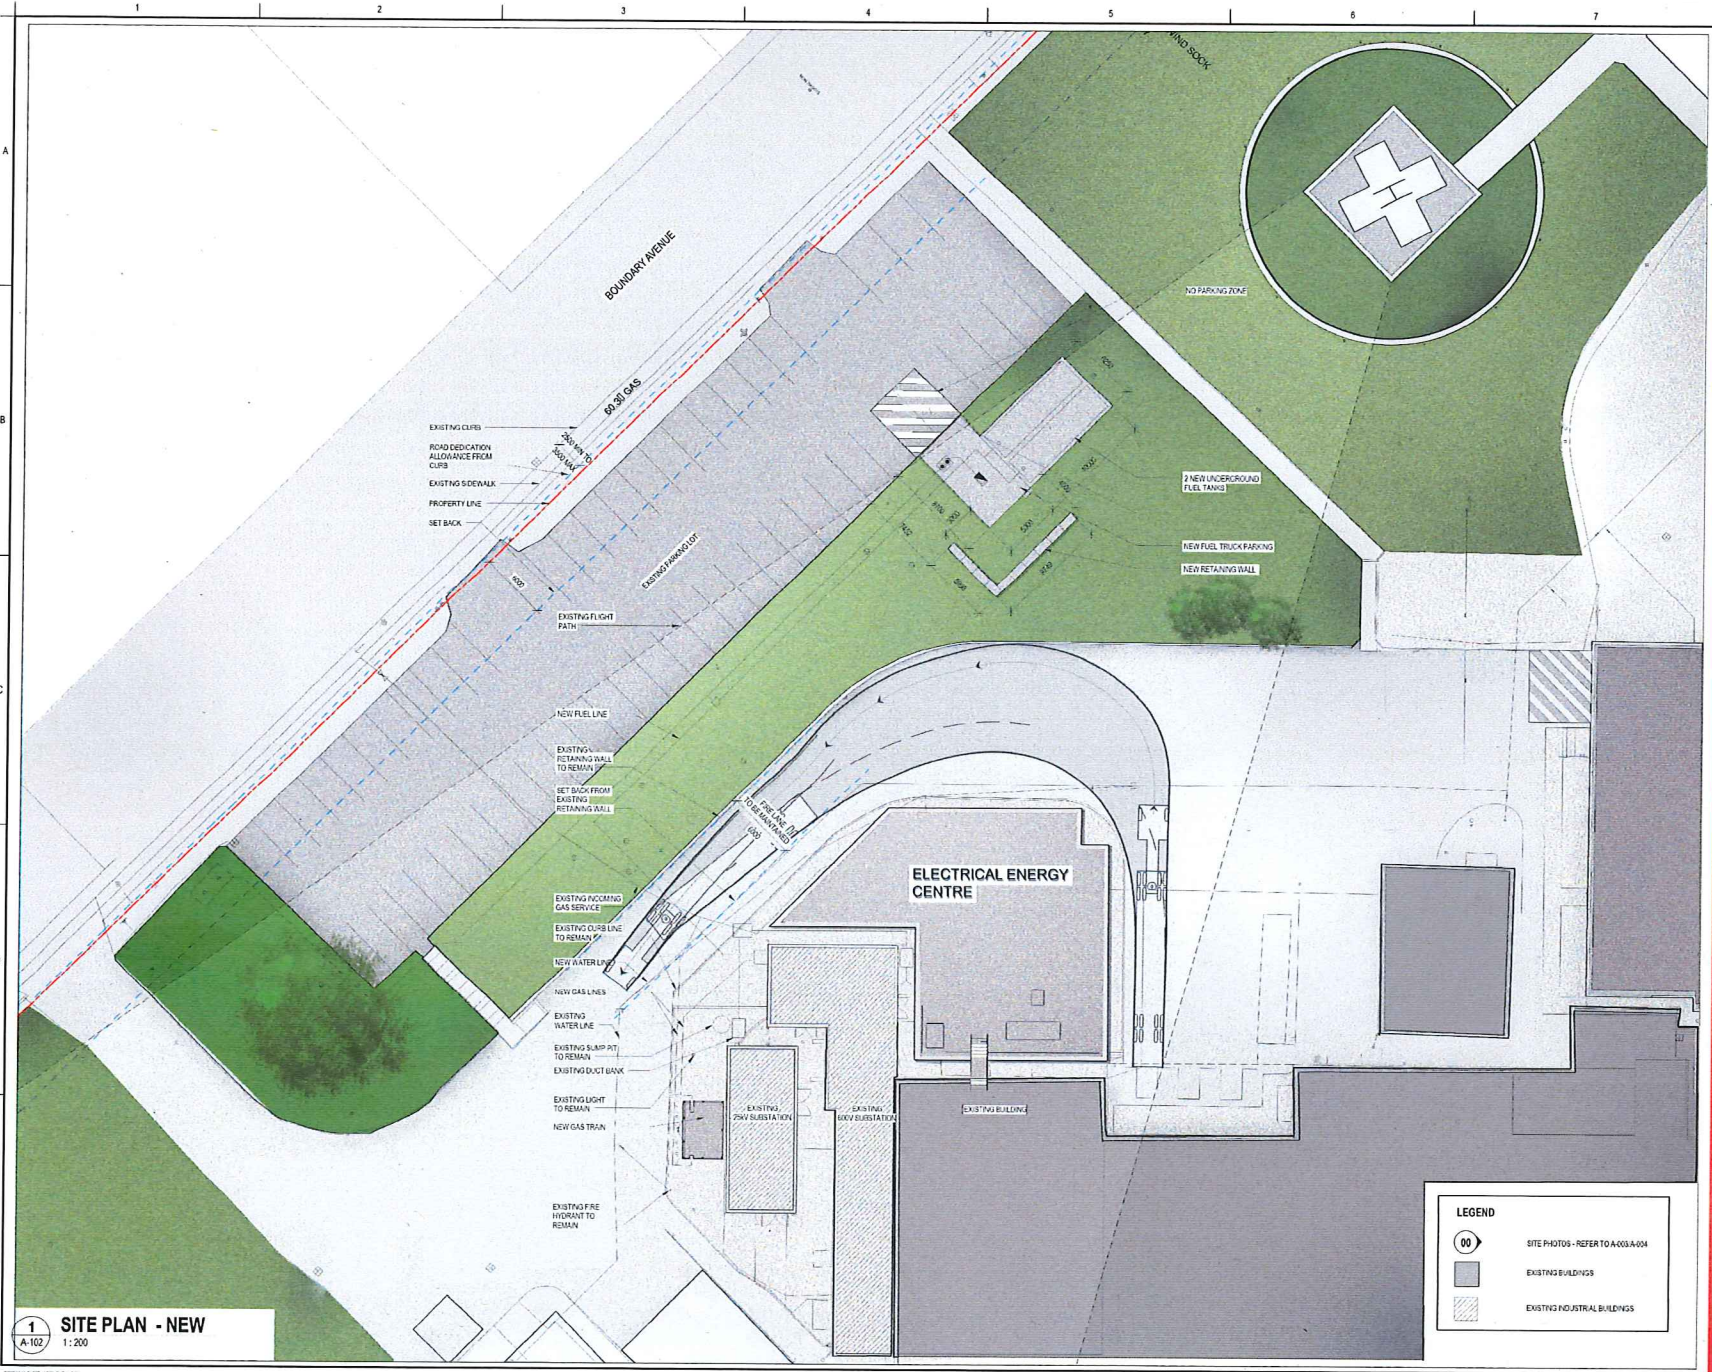

**LEGEND**

	SITE PHOTOS - REFER TO A203-A-004
	EXISTING BUILDINGS
	EXISTING INDUSTRIAL BUILDINGS

**1 SITE PLAN - NEW**  
A-102  
1:200

C:\Users\mshah\OneDrive\Documents\144315071\0071.dwg, ac, 2018-08-29 09:54:14  
144315071-1-2018.dwg